


HWY 412

NAPLES

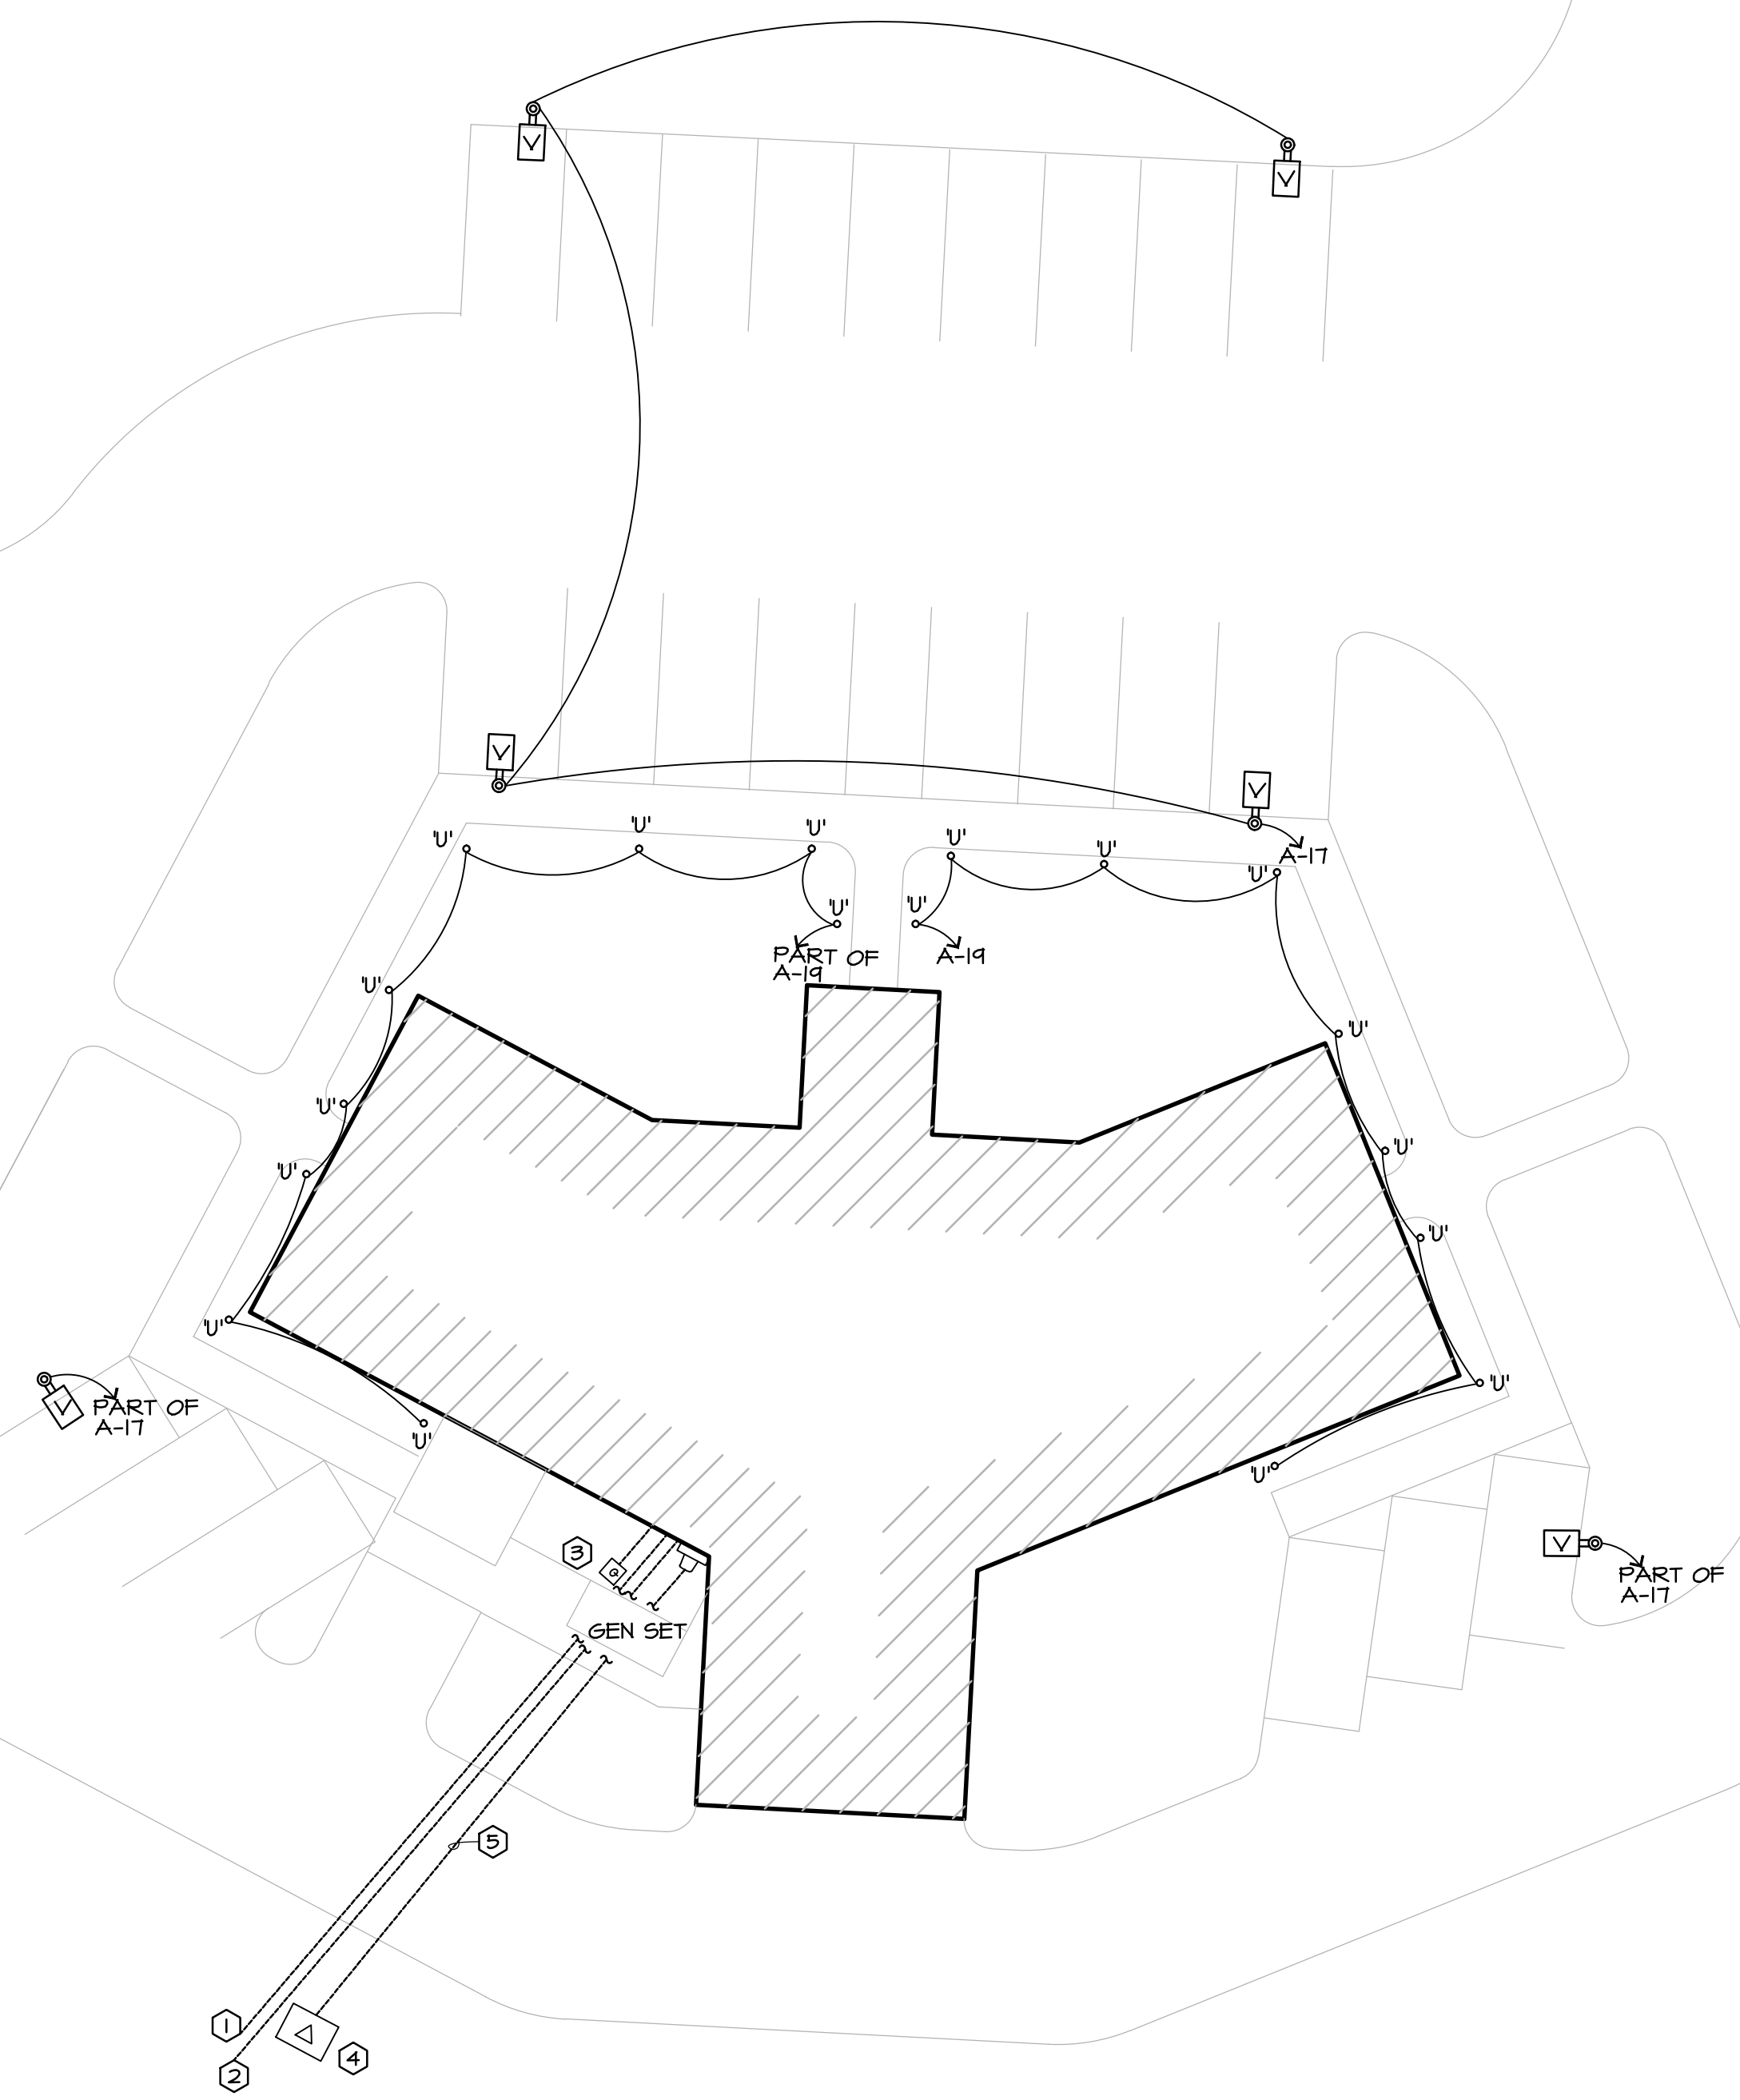


**KEYED ELECTRICAL SITE NOTES**

- ① INSTALL 2-4" CONDUITS WITH A 1/4" PULL TAPE IN EACH ONE TO THE TELEPHONE EASEMENT. COORDINATE EXACT LOCATION WITH LAYNE RHODES WITH A.T.#T. AT 474.442.1977 PRIOR TO INSTALLATION.
- ② INSTALL 1-2" CONDUIT WITH A 1/4" PULL TAPE TO UTILITY EASEMENT IN THE SOUTHWEST CORNER OF THE PROPERTY. COORDINATE EXACT LOCATION WITH MICHAEL MOORE WITH COX COMMUNICATIONS AT 474.717.3730.
- ③ INSTALL QUAZITE BOX IN AN ACCESSIBLE GREEN SPACE AND STUB 2-2" CONDUITS FROM MAIN MECHANICAL ROOM. STUB UP 14" A.F.F. AND CAP FOR FUTURE USE.
- ④ STUB OUT 1-4" CONDUIT TO UTILITY COMPANY TRANSFORMER. COORDINATE WITH OZARKS ELECTRIC'S MIKE PHIPPS AT 474.604.4696 FOR ALL REQUIREMENTS AND LOCATIONS PRIOR TO INSTALLATION.
- ⑤ IDENTIFY OUTDOOR UNDERGROUND LINES WITH CONTINUOUS STRIP OF PLASTIC UTILITY MARKER. TAPE SHOULD STATE AT REGULAR INTERVALS: " CAUTION (ELECTRICAL) PIPE BELOW". INSTALL TAPE ONE FOOT DIRECTLY ABOVE PIPE BEFORE BACKFILLING TO GRADE.

① ELECTRICAL SITE PLAN  
1/16" = 1'-0"



**HSA Engineering**  
479 / 452 / 8922 office  
5701 Euper Lane, Ste A  
Fort Smith, AR 72903  
HSAConsultants.com

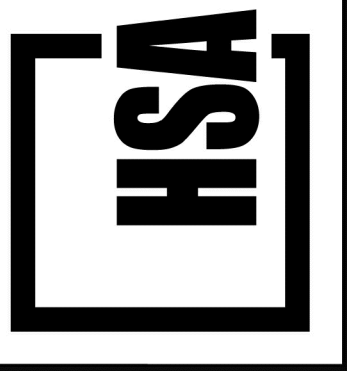

NEW OFFICES FOR:  
**FARM CREDIT SERVICES**  
U.S. HIGHWAY 412  
TONTITOWN, ARKANSAS

REVISIONS	

JOB NUMBER  
15-030


DATE  
06-02-2015

**SHEET**  
**ES1.0**

COPYRIGHT 2015  
THESE DRAWINGS AND SPECIFICATIONS  
ARE THE EXCLUSIVE PROPERTY OF  
HSA ENGINEERING CONSULTING SERVICES, INC.  
USE OR REPRODUCTION IS PROHIBITED  
WITHOUT WRITTEN CONSENT.

Large Scale Dev Set



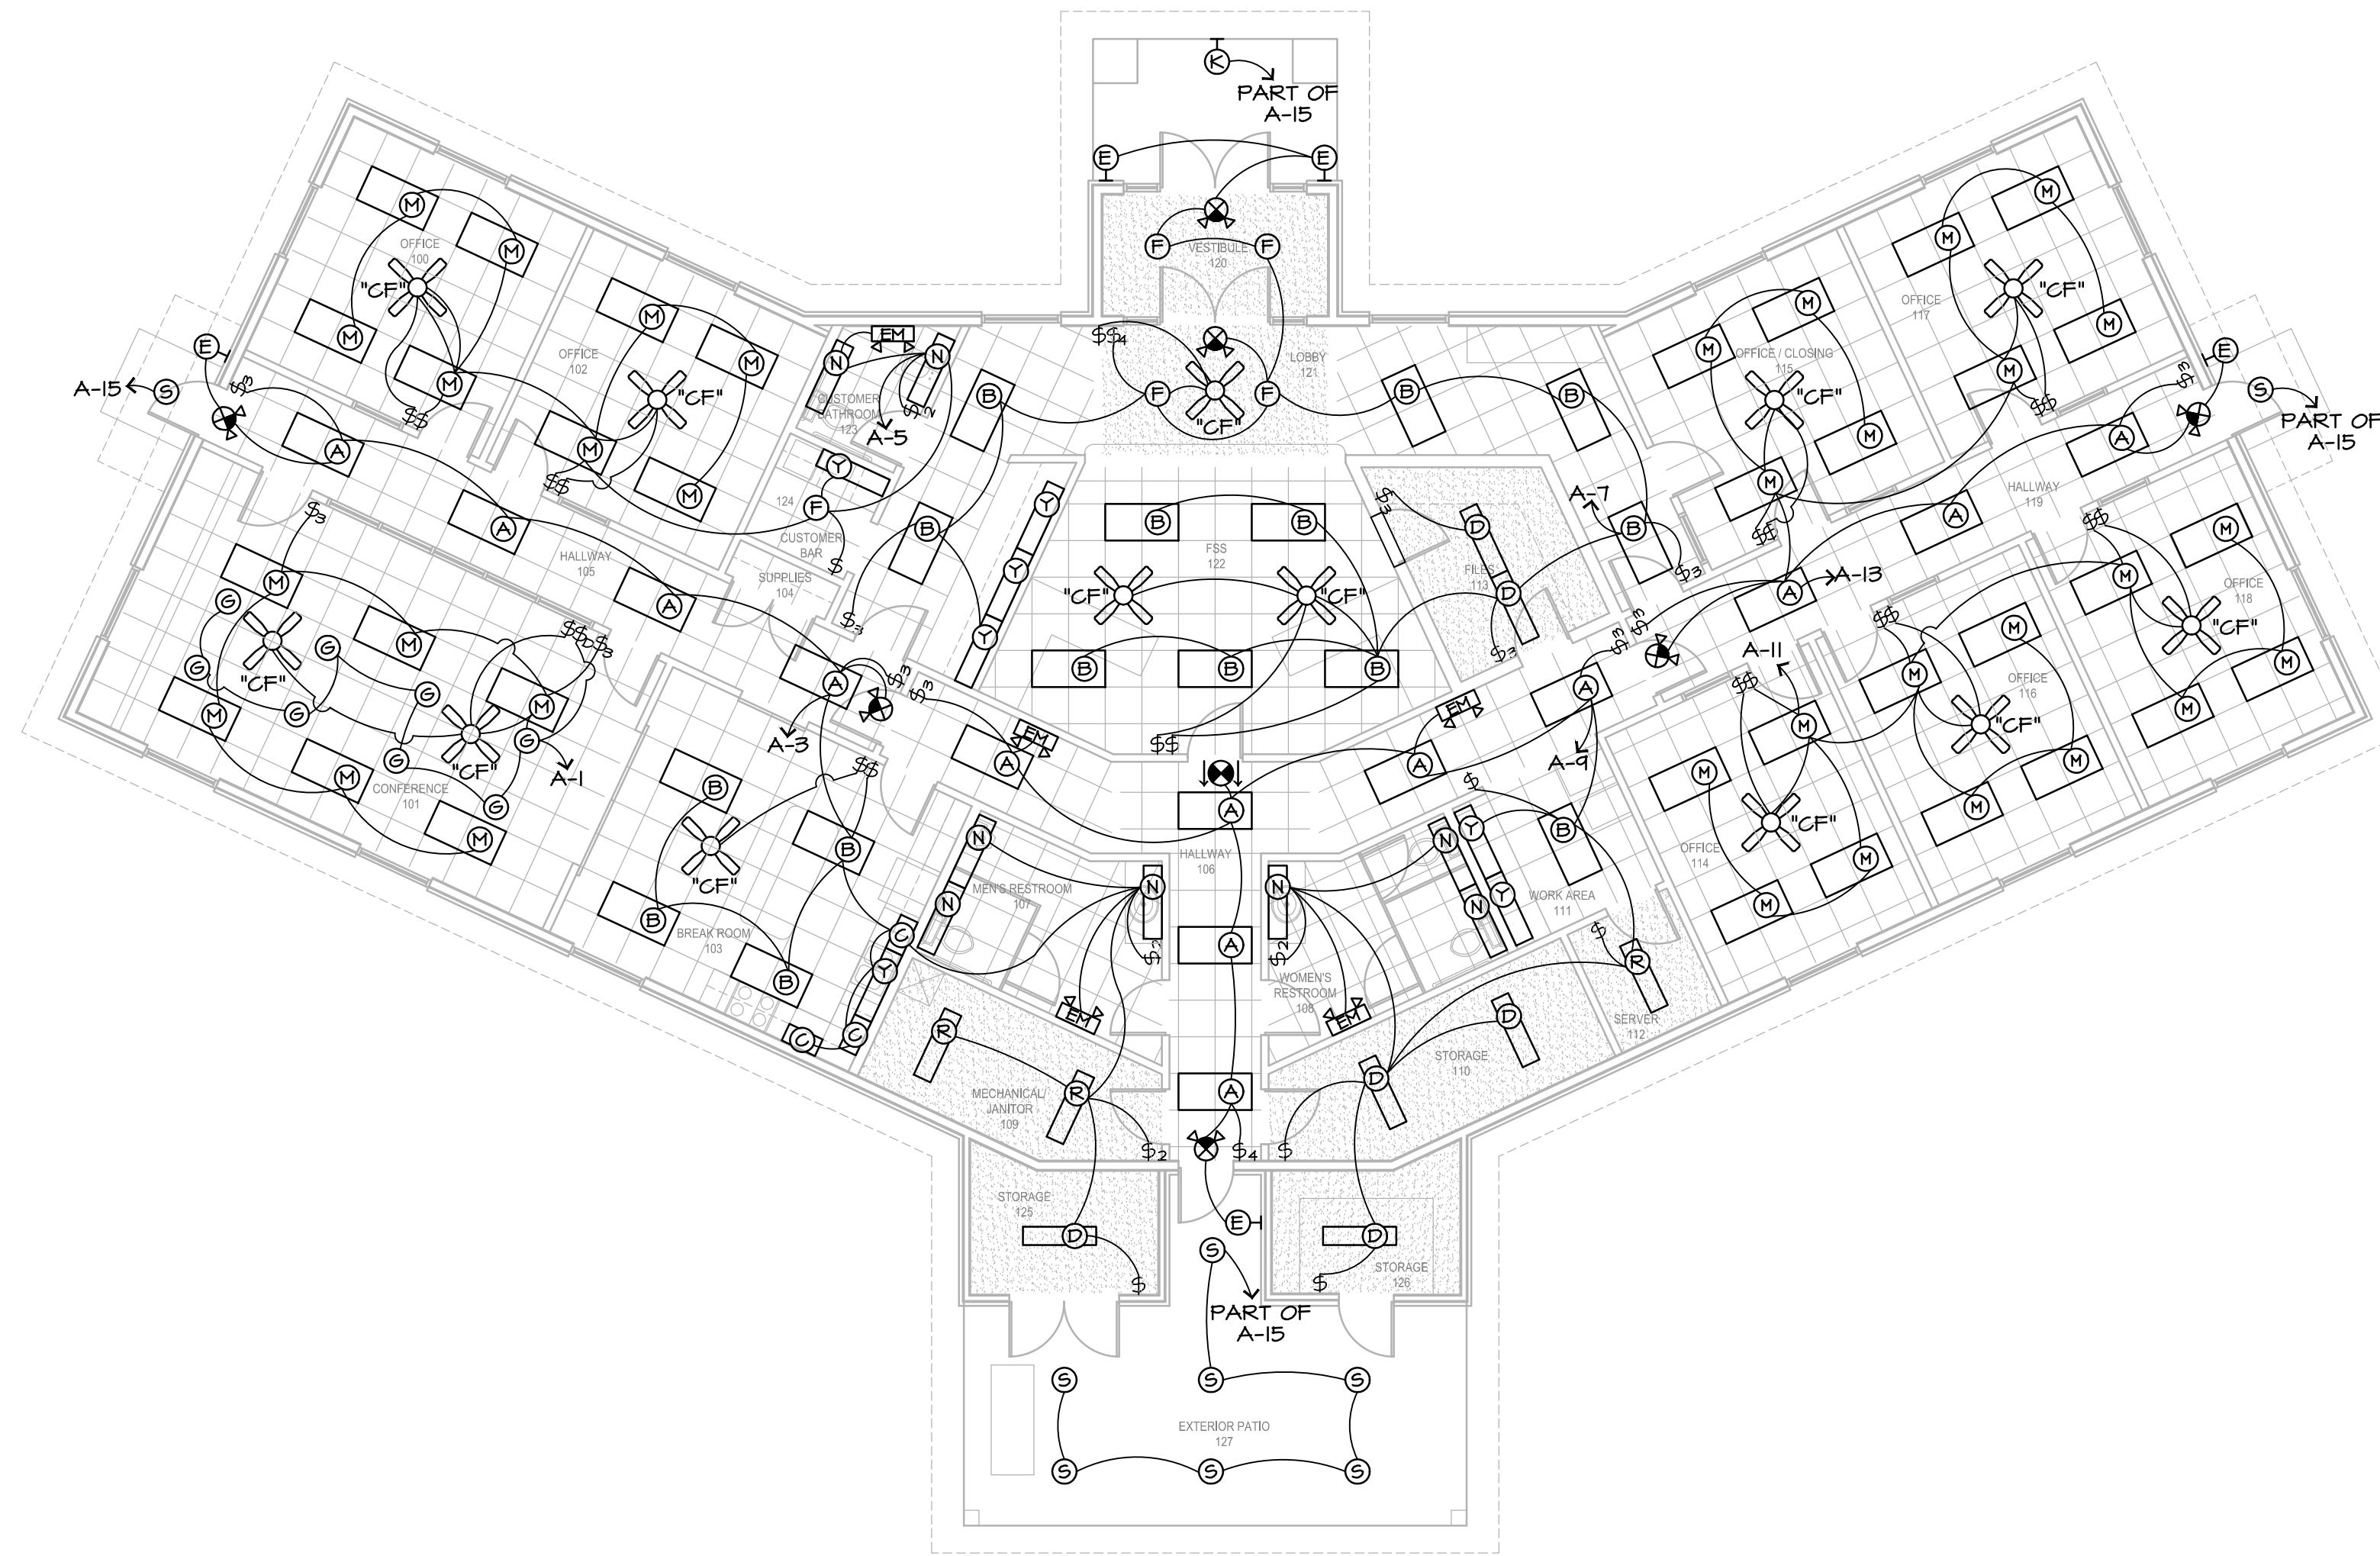

① ELECTRICAL LIGHTING PLAN  
1/8"=1'-0"



**HSA Engineering**  
479 / 452 / 8922 office  
5701 Euper Lane, Ste A  
Fort Smith, AR 72903  
HSAConsultants.com



NEW OFFICES FOR:  
**FARM CREDIT SERVICES**  
U.S. HIGHWAY 412  
TONTITOWN, ARKANSAS

ELECTRICAL LIGHTING PLAN	REVISIONS
JOB NUMBER	15-030
DATE	06-02-2015

**SHEET**  
**L2.1**

COPYRIGHT 2015  
THESE DRAWINGS AND SPECIFICATIONS  
ARE THE EXCLUSIVE PROPERTY OF  
HSA ENGINEERING CONSULTING SERVICES, INC.  
USE OR REPRODUCTION IS PROHIBITED  
WITHOUT WRITTEN CONSENT.

Large Scale Dev Set